




**WALL LEGEND:**

	1-HR FIRE BARRIER, U356
	1-HR FIRE PARTITION
	2-HR WALL

- TAGGED NOTES - THIS SHEET**
- ① LOCATE CONDENSING UNITS PER SITE PLAN. FOLLOW ALL MFG REQUIREMENTS FOR REFRIGERANT PIPING INSTALLATION.
  - ② GARAGE MEETS NATURAL VENTILATION REQUIREMENTS. SEE ARCH. PLANS FOR MORE INFORMATION.

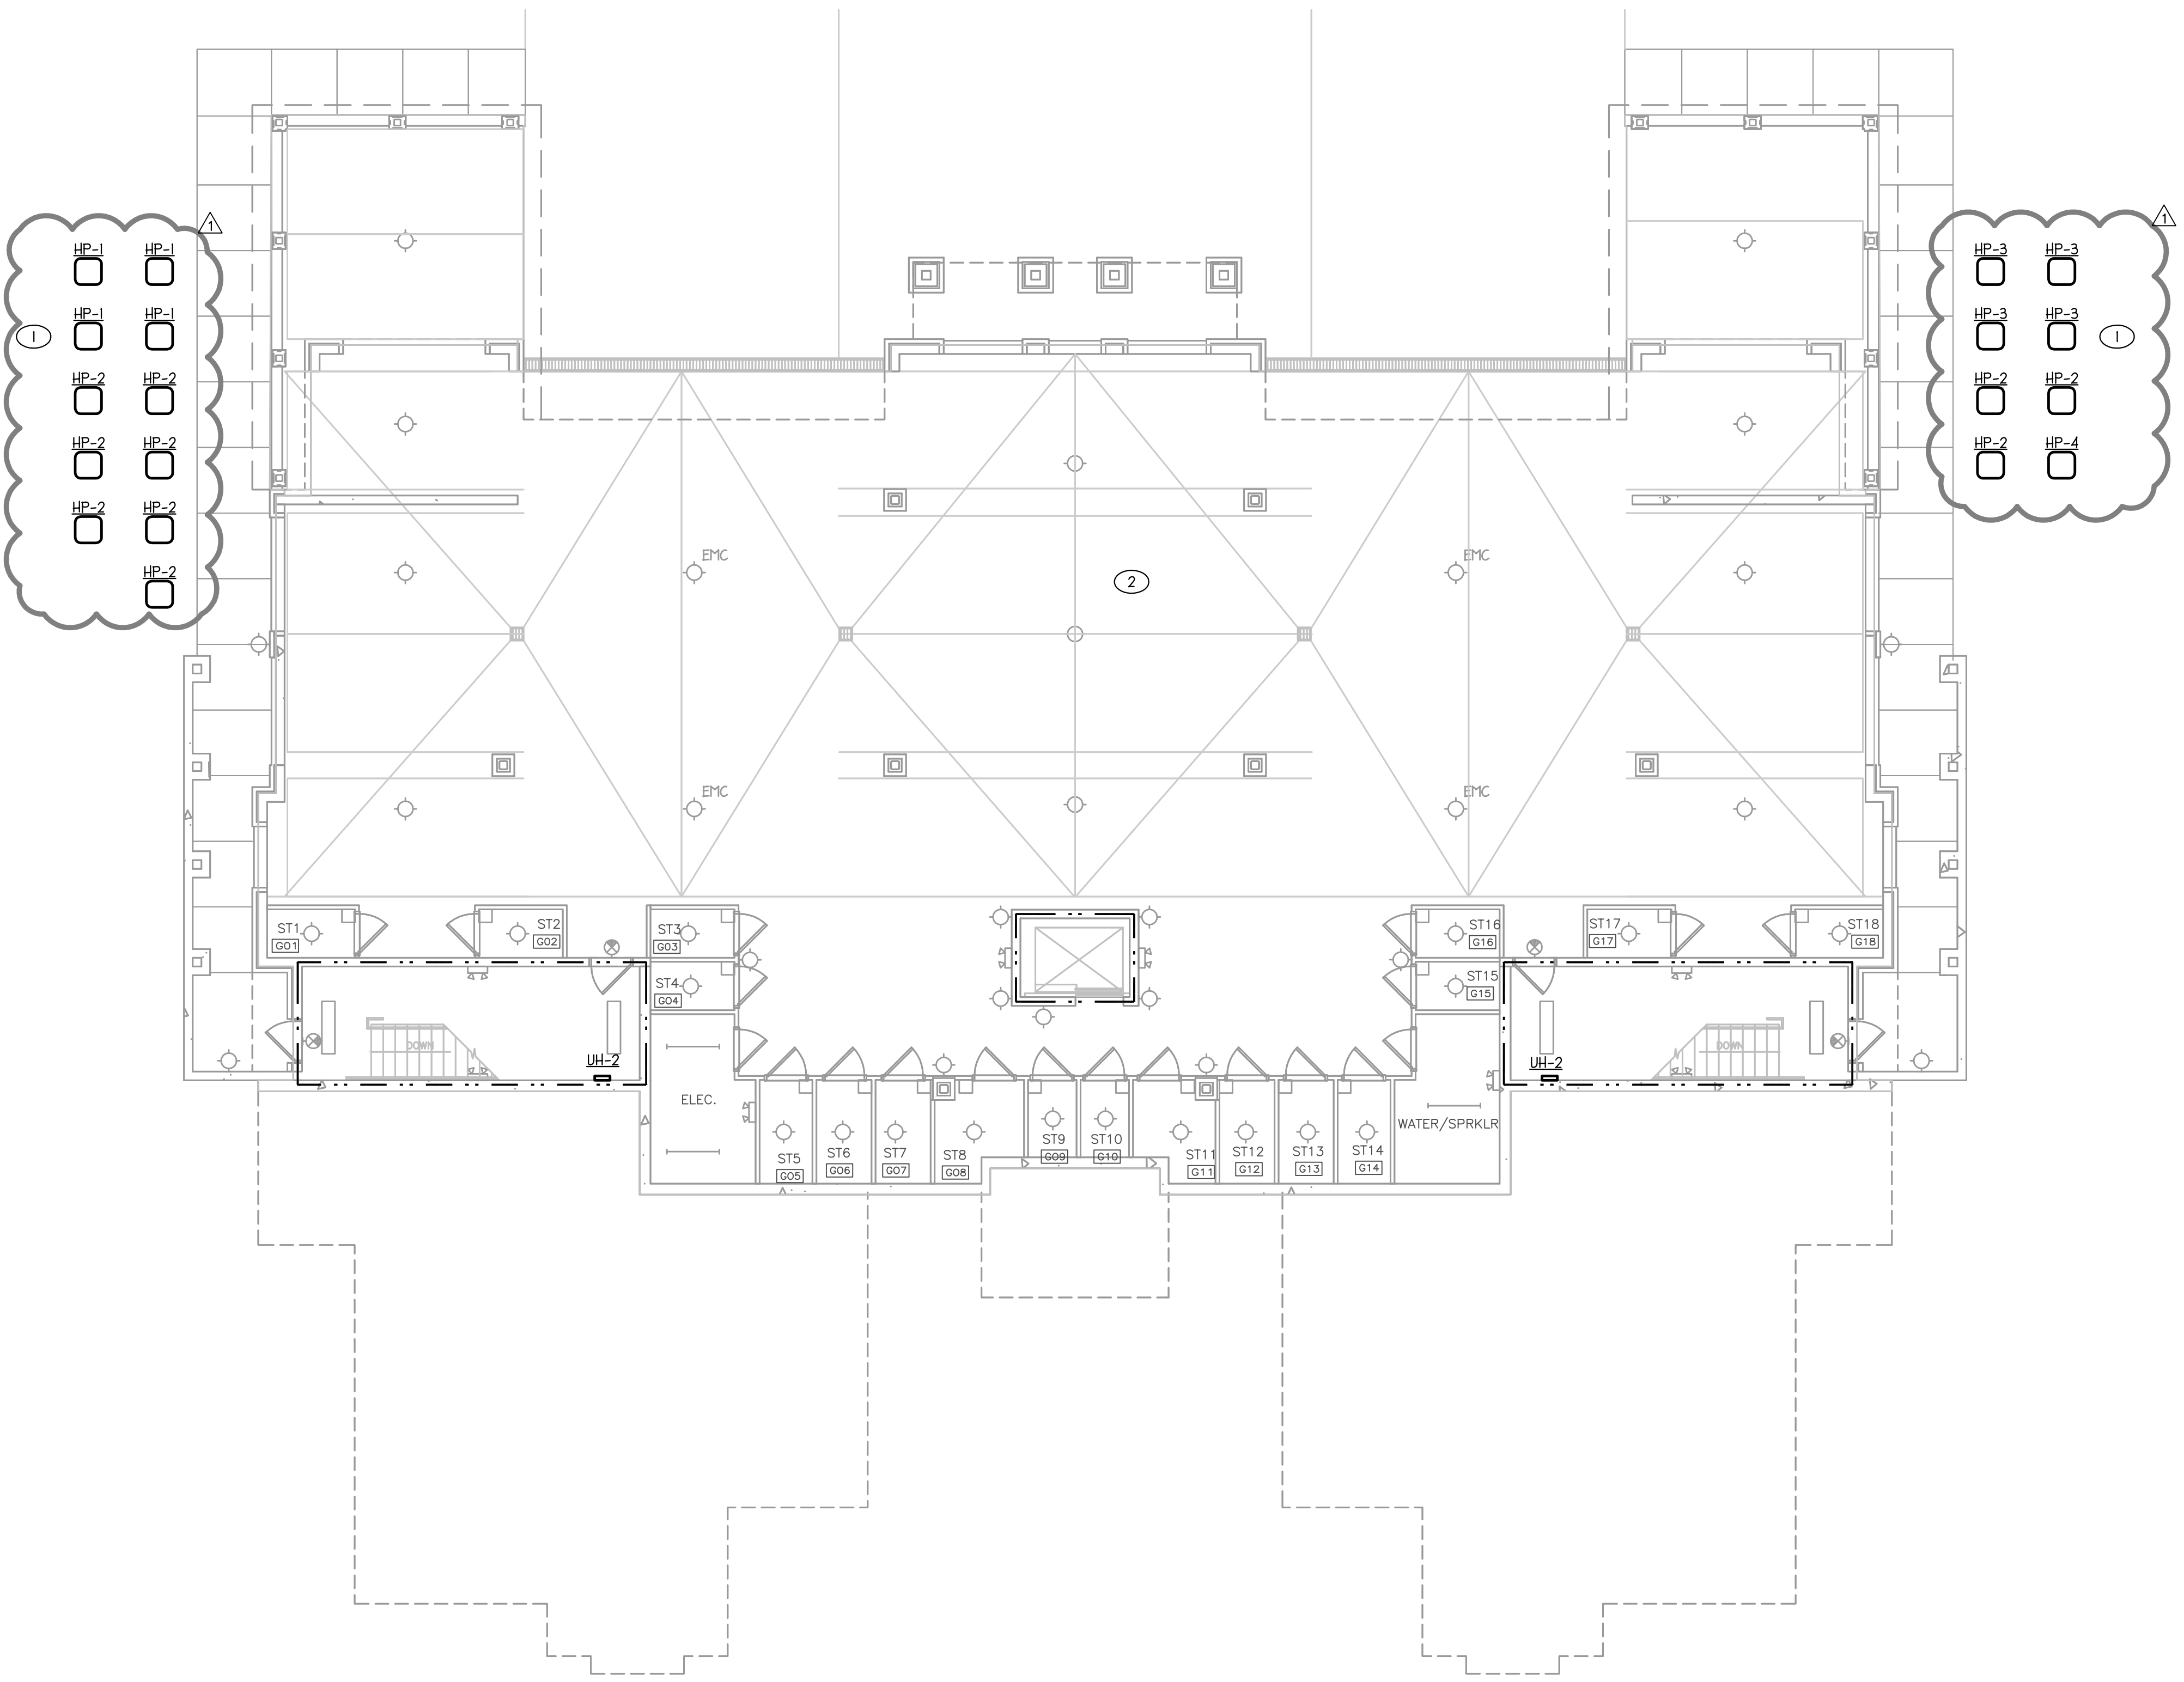

**1 BASEMENT GARAGE LEVEL**  
1/8" = 1'-0"

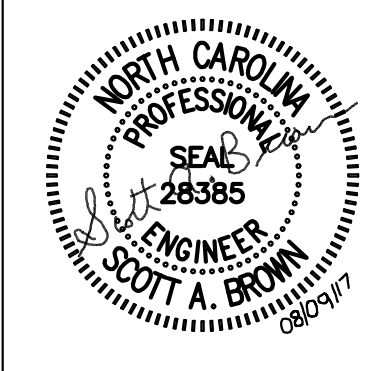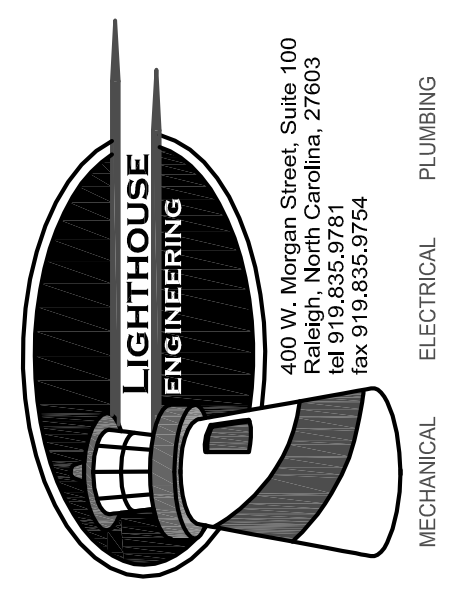

PROJECT:	WOP-05115	DATE	06.16.2017
REVISIONS:			
▲ CITY COMMENTS		08.07.17	

DRAWN BY:	PWI
CHECKED BY:	SAB
CONTENT:	MECHANICAL
	BUILDING PLAN

04-1000140-05.dwg  
Aug 09, 2017 10:17:09

©2016 LIGHTHOUSE ENGINEERING, PA. EXPRESSLY RESERVES ITS COMMON LAW COPYRIGHT AND OTHER PROPERTY RIGHTS IN THESE PLANS. THESE PLANS ARE NOT TO BE REPRODUCED, CHANGED OR COPIED IN ANY FORM OR MANNER WHATSOEVER, NOR ARE THEY TO BE ASSIGNED TO ANY THIRD PARTY WITHOUT FIRST OBTAINING THE EXPRESSED WRITTEN PERMISSION AND CONSENT OF LIGHTHOUSE ENGINEERING, PA.